



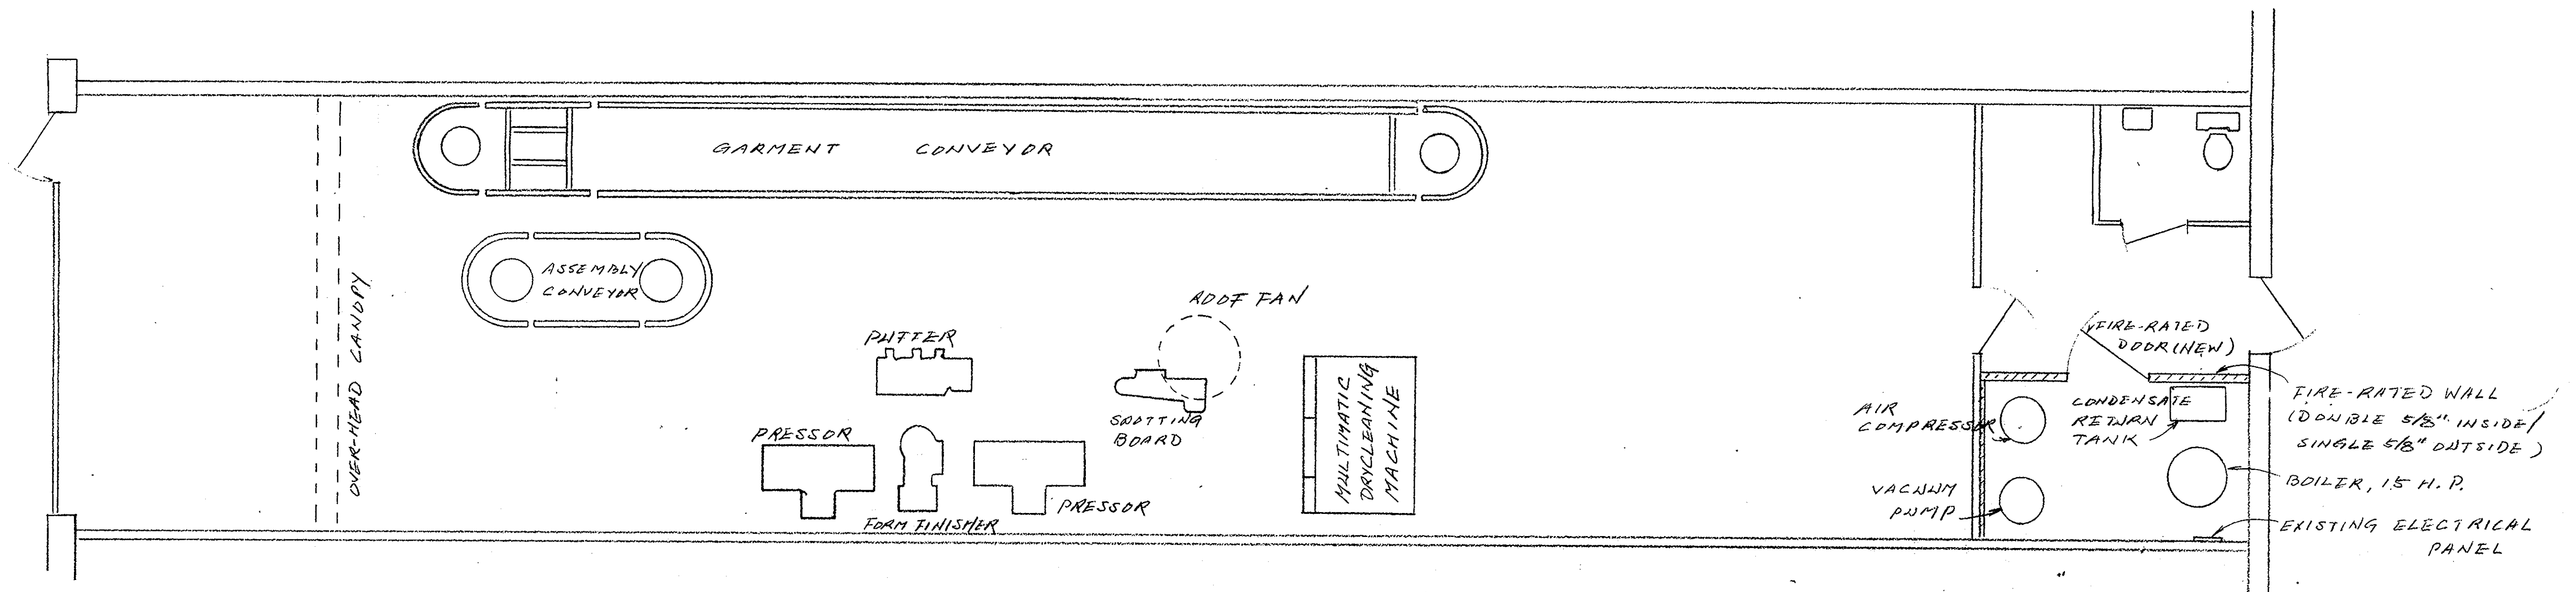

FLOOR PLAN

NOTE: A SPRINKLER SYSTEM EXISTS AT THE STORE. A SPRINKLER HEAD WITH RELEASE TEMPERATURE OF 180°F OR HIGHER IF REQUIRED WILL BE INSTALLED IN THE BOILER ROOM.

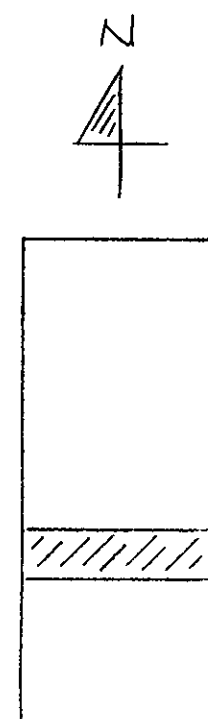

site plan

SHREWSBURY PLAZA
SHREWSBURY, N. J.

ELECTRICAL PLAN		
230 VOLTS 3 PHASES		
POLE	AMP	ASSIGNMENT
3	40	DRYCLEANING MACHINE
3	20	AIR COMPRESSOR
1	15	VACUUM PUMP
1	15	BOILER
1	10	FOAM FINISHER
1	15	GARMENT CONVEYOR
1	15	ASSEMBLY CONVEYOR

LEGEND

EXISTING CONSTRUCTION
NEW CONSTRUCTION

PROJECT KIM'S CLEANERS SHREWSBURY, N. J.		DATE 7-24-91
TITLE DETAILED PLANS		SCALE 1/4" = 1'
DRAWN DW		DRAWING NO. 1 of 1
HITECH ENGINEERING INC.		
DONG S. WHANG, P.E., Ph.D.		
N.J.P.E. Lic. No. 22119	286 COUNTY ROAD	34-46 200th ST.
N.Y.P.E. Lic. No. 063625	TENAFLY, N.J. 07670	BAYSIDE, N.Y. 11361
DELAWARE P.E. Lic. No. 4753	(201) 816-0909	(718) 389-3822
N.Y.C. Asbestos Inv. Lic. No. 02617	FAX: (201) 816-9401	

Dong S. Whang